

**ECOSOLUTIONS LLC**  
 315 Plains Road  
 Westford, Vermont 05494  
 www.ecosolddesigns.com



Roth Ecological Design Int. LLC  
 925 Bethel Street, Suite 100  
 Honolulu, HI 96813  
 www.rothecologicaldesign.com




DATE 07/01/13	JOB NO. 11-025	DESIGNED BY DHW	DRAWN BY JRT
<p>The work is covered by the professional seal and signature of the engineer. The engineer is not responsible for the design or construction of the work unless the work is specifically identified as being the responsibility of the engineer.</p>			Signature

Repair Recirculation Line (January 2018)

Metal Salts (TP Removal and pH Control)

Install System (not installed initially)

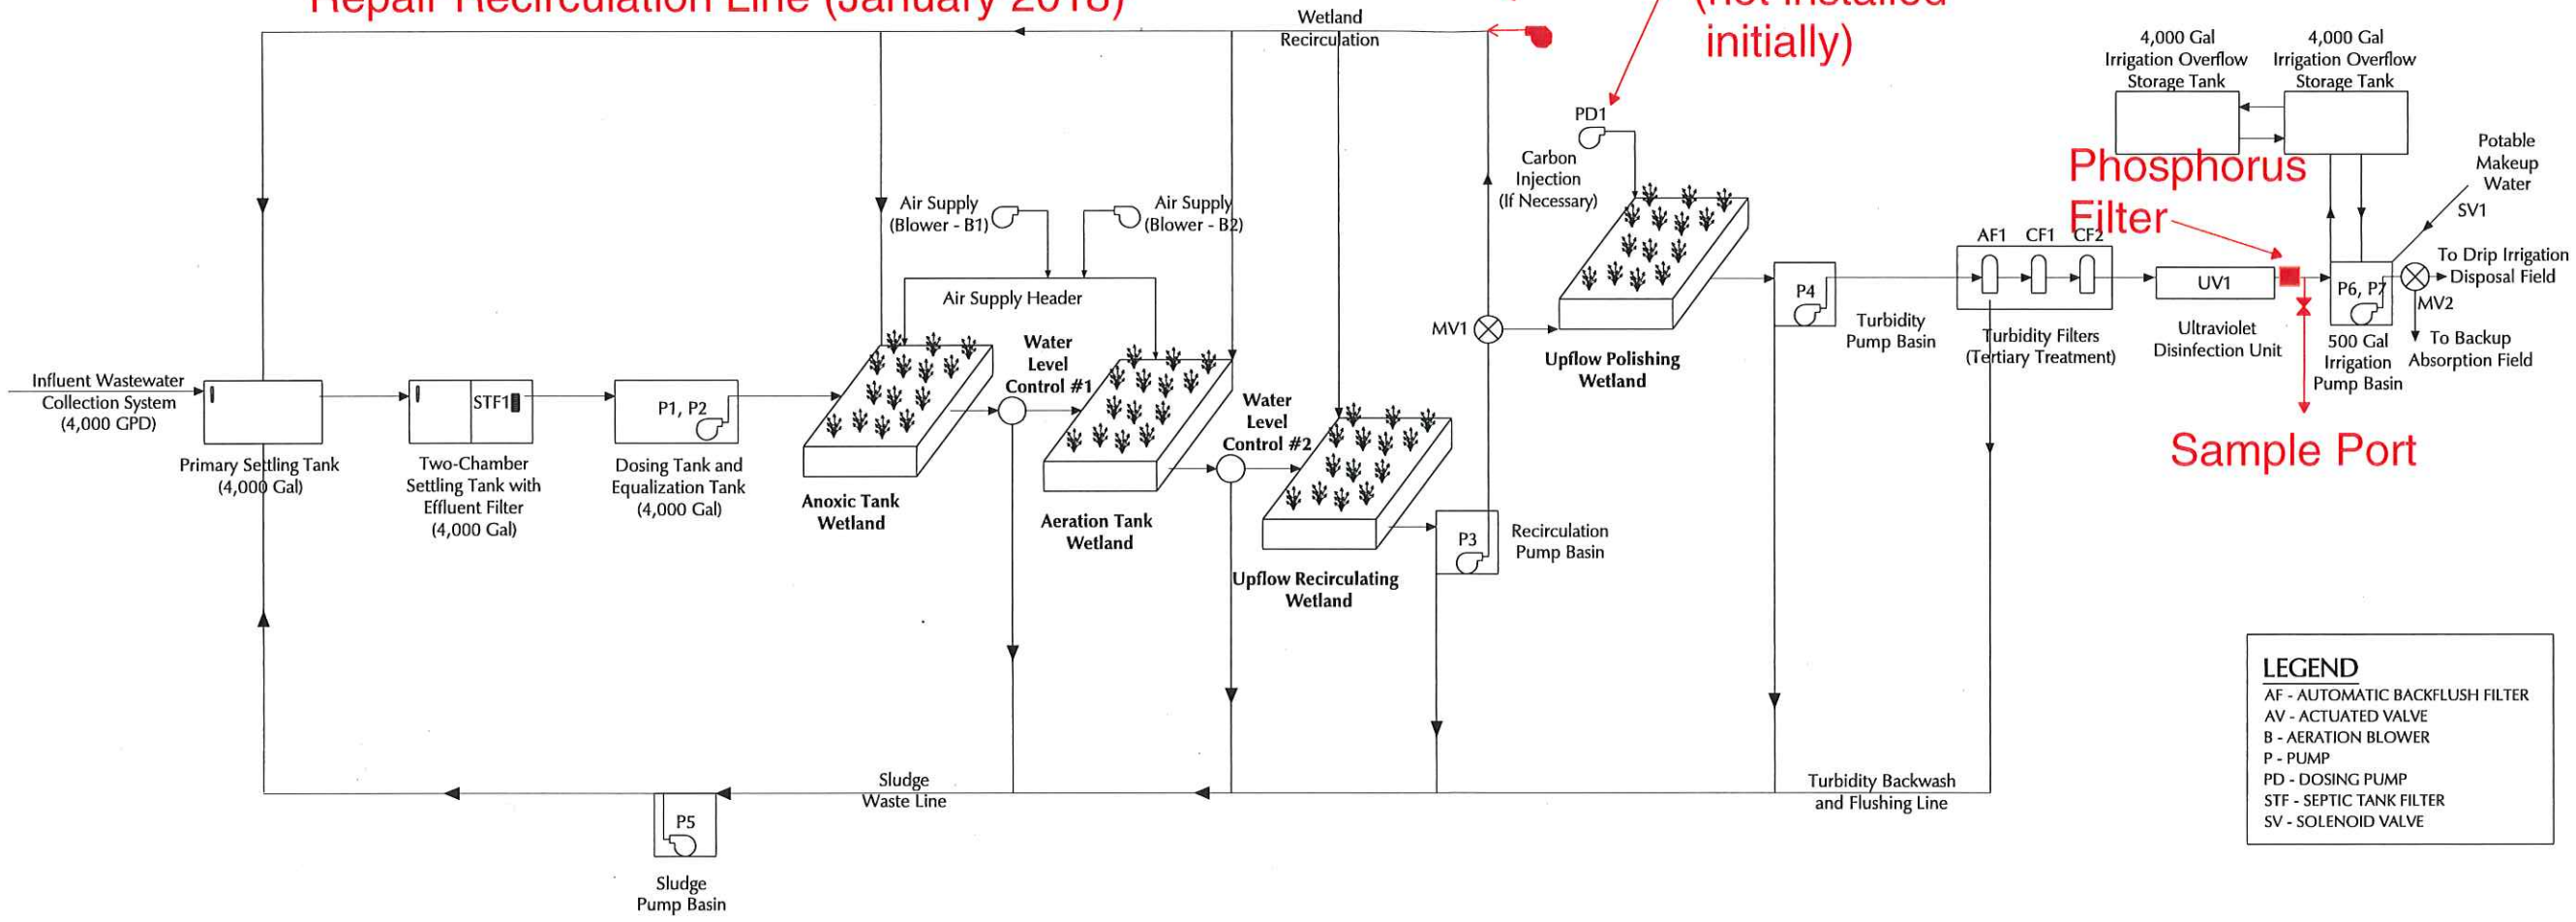

Process Flow Diagram  
 Scale: None

**LEGEND**

- AF - AUTOMATIC BACKFLUSH FILTER
- AV - ACTUATED VALVE
- B - AERATION BLOWER
- P - PUMP
- PD - DOSING PUMP
- STF - SEPTIC TANK FILTER
- SV - SOLENOID VALVE

REV.	DATE	DESCRIPTION	BY

PROCESS FLOW DIAGRAM

ARCHITECTURE: RICHARD MATSUNAGA & ASSOCIATES  
 PLANNING: POTOMAC ENERGY  
 ARCHITECTS INC. 100 WEST 10TH STREET, 10TH FLOOR, ANNAPOLIS, MARYLAND 21401-1010

Project: KAISER PERMANENTE  
 KONA MEDICAL OFFICE BUILDING

Maryl Group Construction, Inc.  
 55 Merchant Street, Suite 2900  
 Honolulu, HI 96813  
 Tel: 808.545.2920 Fax: 808.545.3694

ORIGINAL

RECEIVED  
 MAY 23 2018  
 STATE OF HAWAII  
 LAND USE COMMISSION

SHEET NUMBER  
**WW7**  
 64 of 316 SHEETS